



ADDENDUM NO. 1

TO THE PLANS, SPECIFICATIONS, PROPOSAL AND CONTRACT FOR THE CITY OF LACEY

HAWKS PRAIRIE RESERVOIR REHABILITATION

LACEY CONTRACT NO. PW 2021-19

TO ALL PLAN HOLDERS:

You are hereby notified of the following changes, revisions, deletions, additions, corrections and/or clarifications to the plans, specifications, and contract documents for the *Hawks Prairie Reservoir Rehabilitation* project. This addendum is made part of these contract documents as though it was originally included in the Contract. The Contractor shall note the location of the Addenda Receipt Acknowledgement on Page B-4 of the Contract Proposal.

 
Issued this 1st day of April 2026.

ADDITIONS, MODIFICATIONS, AND/OR DELETIONS TO THE PLANS AND SPECIFICATIONS

ITEM NO. 1:

Plan Cover Sheet (1 of 42)

Replace Sheet 1 with the attached sheet.



Scott Egger, P.E.
Public Works Director

LACEY CONTRACT NO. PW#2021-19
 LACEY DRAWING NO. D-23-11
 SPRING 2026
 VOLUME 1 OF 1


CITY OF LACEY

BID READY

HAWKS PRAIRIE RESERVOIR REHABILITATION

SHEET LIST TABLE

SHEET NO.	SHEET TITLE	DWG NO.
01	COVER	COV
02	GENERAL NOTES	G01
03	EXISTING SITE PLAN	C01
04	DEMOLITION AND TESC PLAN	C02
05	CONSTRUCTION GRADING PLAN	C03
06	CONSTRUCTION GRADING SECTIONS	C04
07	NEW GRADING PLAN	C05
08	NEW GRADING AND SUBGRADE SECTIONS	C06
09	NEW OVERALL SITE PLAN	C07
10	NEW SITE AND WATER MAIN PLAN	C08
11	NEW DRAINAGE AND STORM PLAN	C09
12	NEW PAVING PLAN	C10
13	SITE DETAILS 1	D01
14	SITE DETAILS 2	D02
15	STANDARD DETAILS 1	D03
16	STANDARD DETAILS 2	D04
17	GENERAL STRUCTURAL NOTES 1	S01
18	GENERAL STRUCTURAL NOTES 2	S02
19	RESERVOIR DEMOLITION PLAN	S03
20	FOUNDATION PLAN AND DETAILS	S04
21	ROOF PLAN AND DETAILS	S05
22	STRUCTURAL SECTIONS AND DETAILS	S06
23	STRUCTURAL DETAILS	S07
24	RESERVOIR MECHANICAL PLAN	M01
25	RESERVOIR MECHANICAL SECTIONS	M02
26	MECHANICAL VAULT PLAN	M03
27	CONNECTION DETAILS 1	M04
28	CONNECTION DETAILS 2	M05
29	MECHANICAL DETAILS 1	M06
30	MECHANICAL DETAILS 2	M07
31	ELECTRICAL LEGEND	E01
32	ELECTRICAL SITE PLAN	E02
33	BPS ELECTRICAL PLAN	E03
34	RESERVOIR ELECTRICAL PLAN 1	E04
35	RESERVOIR ELECTRICAL PLAN 2	E05
36	ELECTRICAL DETAILS	E06
37	ELECTRICAL SCHEDULES	E07
38	EXISTING MAIN CONTROL PANEL CP01 INPUT AND OUTPUT WIRING 1	E08
39	EXISTING MAIN CONTROL PANEL CP01 INPUT AND OUTPUT WIRING 2	E09
40	EXISTING MAIN CONTROL PANEL CP01 INPUT AND OUTPUT WIRING 3	E10
41	CATHODIC PROTECTION PLAN AND DETAILS	CP01
42	CATHODIC PROTECTION DETAILS	CP02

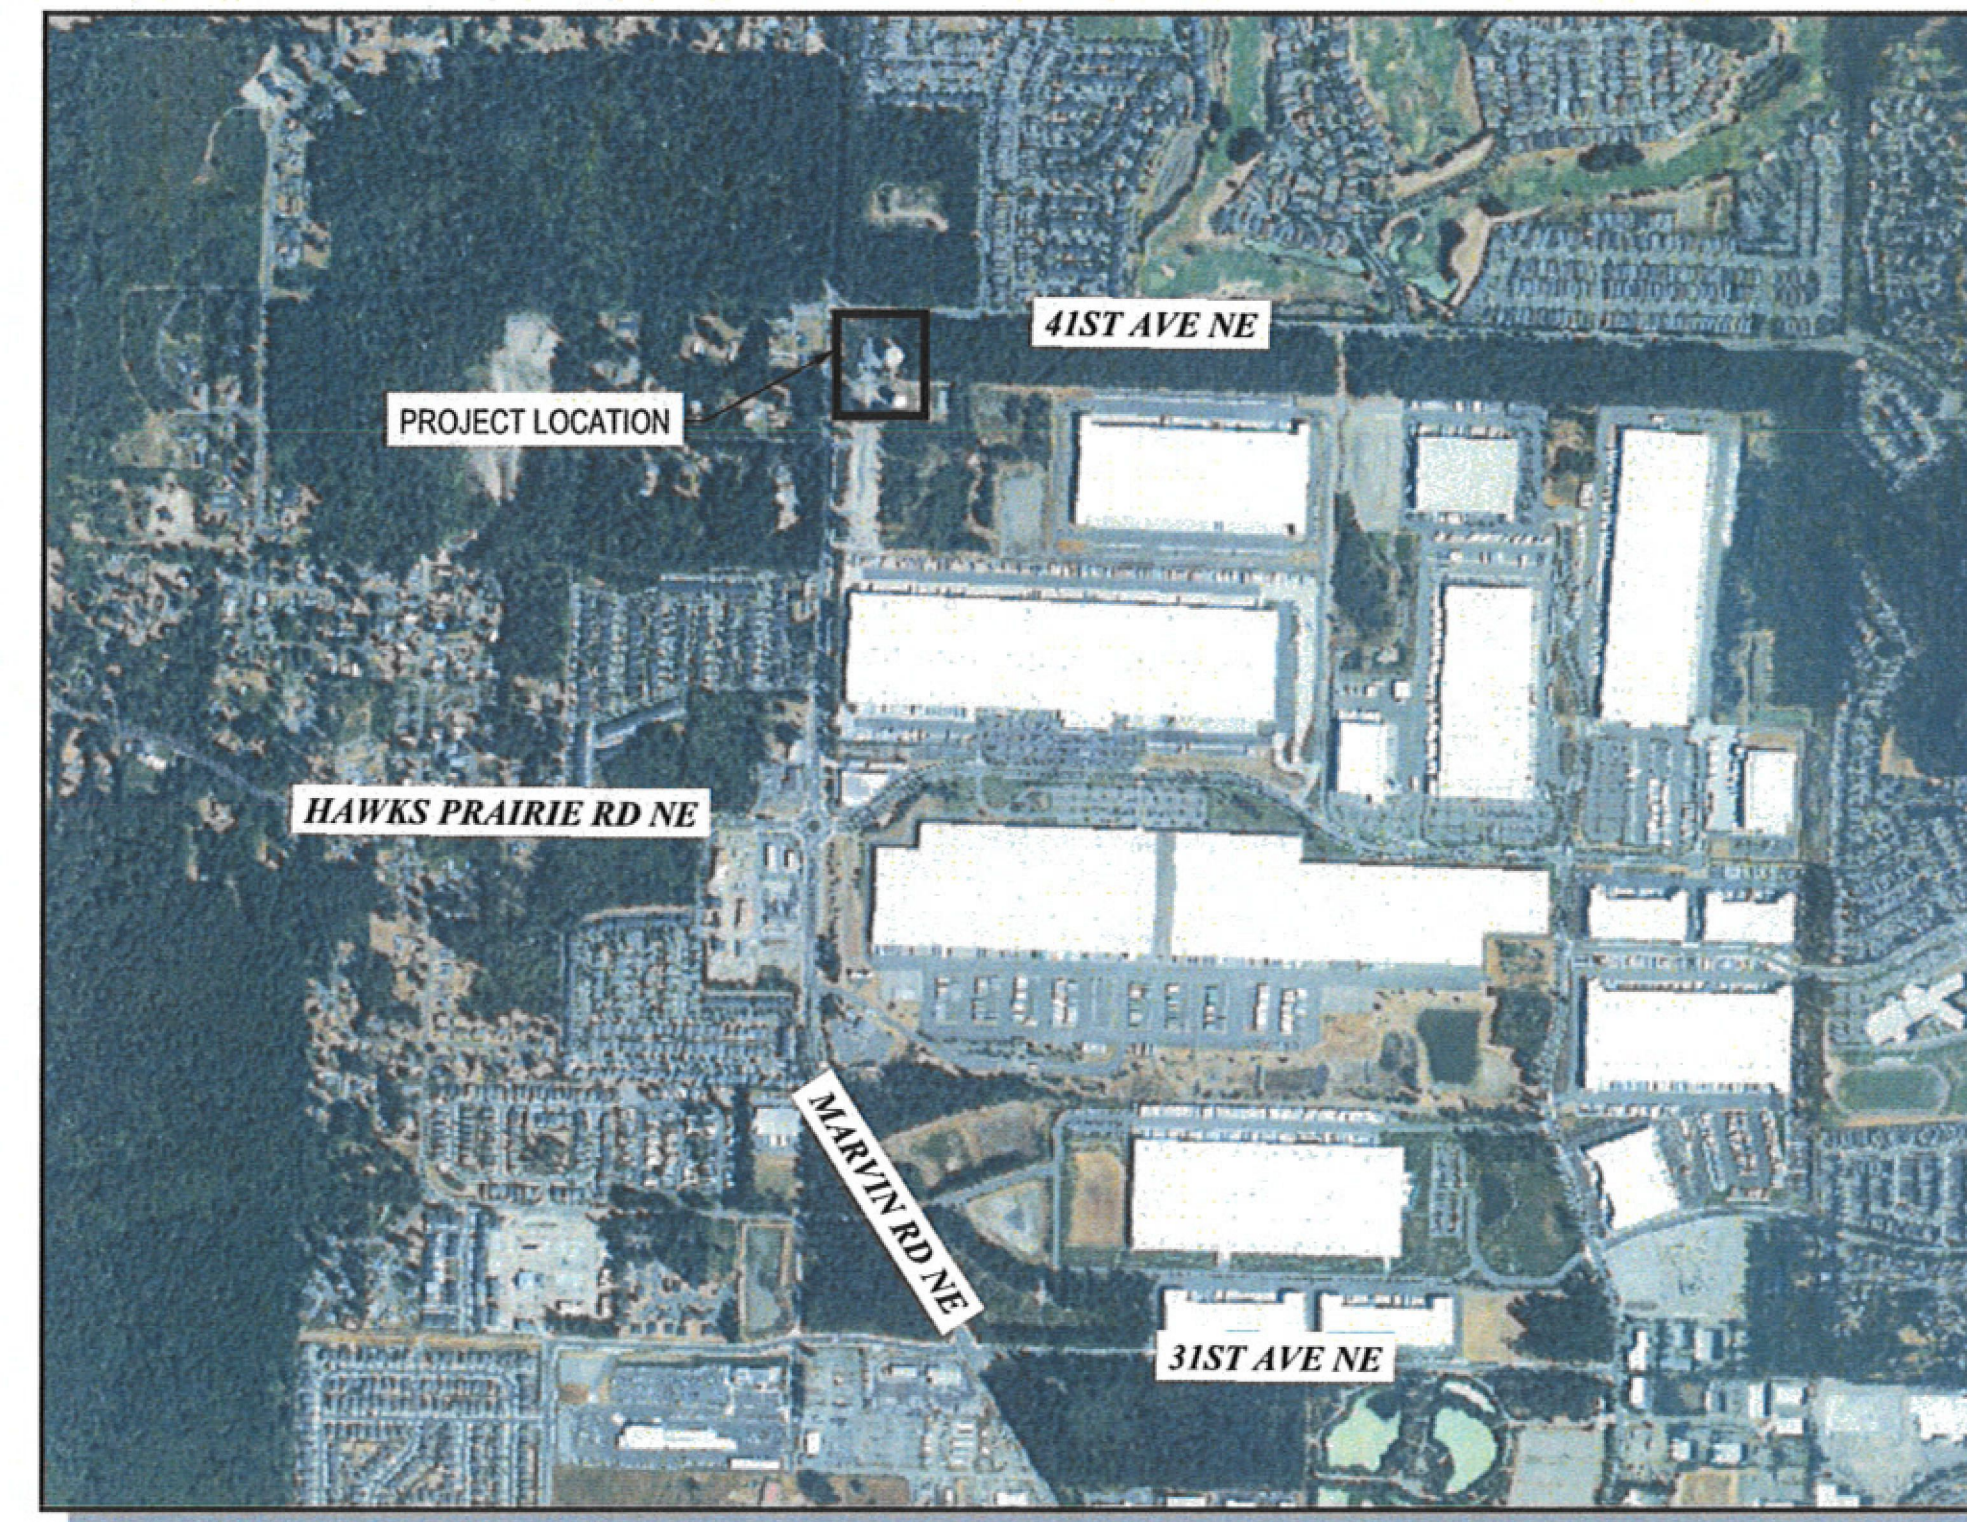


VICINITY MAP
 1" = 1000'



CITY OF LACEY OFFICIALS

MAYOR:	ANDY RYDER
DEPUTY MAYOR:	MALCOLM MILLER
CITY MANAGER:	RICK WALK
PUBLIC WORKS DIRECTOR:	SCOTT EGGER, P.E.
CITY ATTORNEY:	DAVID SCHNEIDER
CITY ENGINEER:	AUBREY COLLIER, P.E. S.E.

CITY COUNCIL:
 LENNY GREENSTEIN
 CAROLYN COX
 NICOLAS DUNNING
 MAREN TURNER
 RYAN SIU

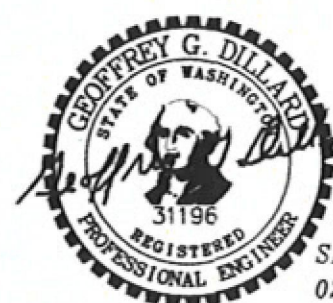

Scott Egger
 DIRECTOR OF PUBLIC WORKS
 DATE: 4/1/26